

This drawing is not to be scaled, all figured dimensions to be used.

All Dimensions and cadastral setting out information to be thoroughly checked on site and all or any discrepancies to be reported to the Architect or Lead Consultant before any work is put in hand.

All work is to comply with the NATIONAL BUILDING REGULATIONS (NBR) AND BUILDING STANDARDS act 103 of 1977 as amended

All work is to comply with all relevant specifications and codes of practice of the SOUTH AFRICAN BUREAU OF STANDARDS (SABS) / SOUTH AFRICAN NATIONAL STANDARDS (SANS) and amendments thereto.

HEALTH AND SAFETY: All construction activities to conform to the OCCUPATIONAL HEALTH AND SAFETY ACT 1993 (Act No 85 of 1993)

All materials and workmanship to be as per the MODEL PREAMBLES FOR TRADES 2008, and any further additional preambles as noted in the Bills of Quantities.

All work is to comply with all relevant specifications and codes of practice of the NATIONAL HOME BUILDERS REGISTRATION COUNCIL (NHBC) (Where applicable)

ELECTRICAL Engineer: (Where applicable) All materials and workmanship to be as specified on the Consultants drawings.


STRUCTURAL and CIVIL Engineer: (Where applicable) All materials and workmanship to be as specified on the Consultants drawings.

HVAC Engineer: (Where applicable) All materials and workmanship to be as specified on the Consultants drawings.

RATIONAL FIRE Engineer: (Where applicable) All materials and workmanship to be as specified on the Consultants drawings.

WET SERVICES Engineer: (Where applicable) All materials and workmanship to be as specified on the Consultants drawings.


SPECIALIST CONSULTANTS (Where applicable) All materials and workmanship to be as specified on the Consultants drawing.

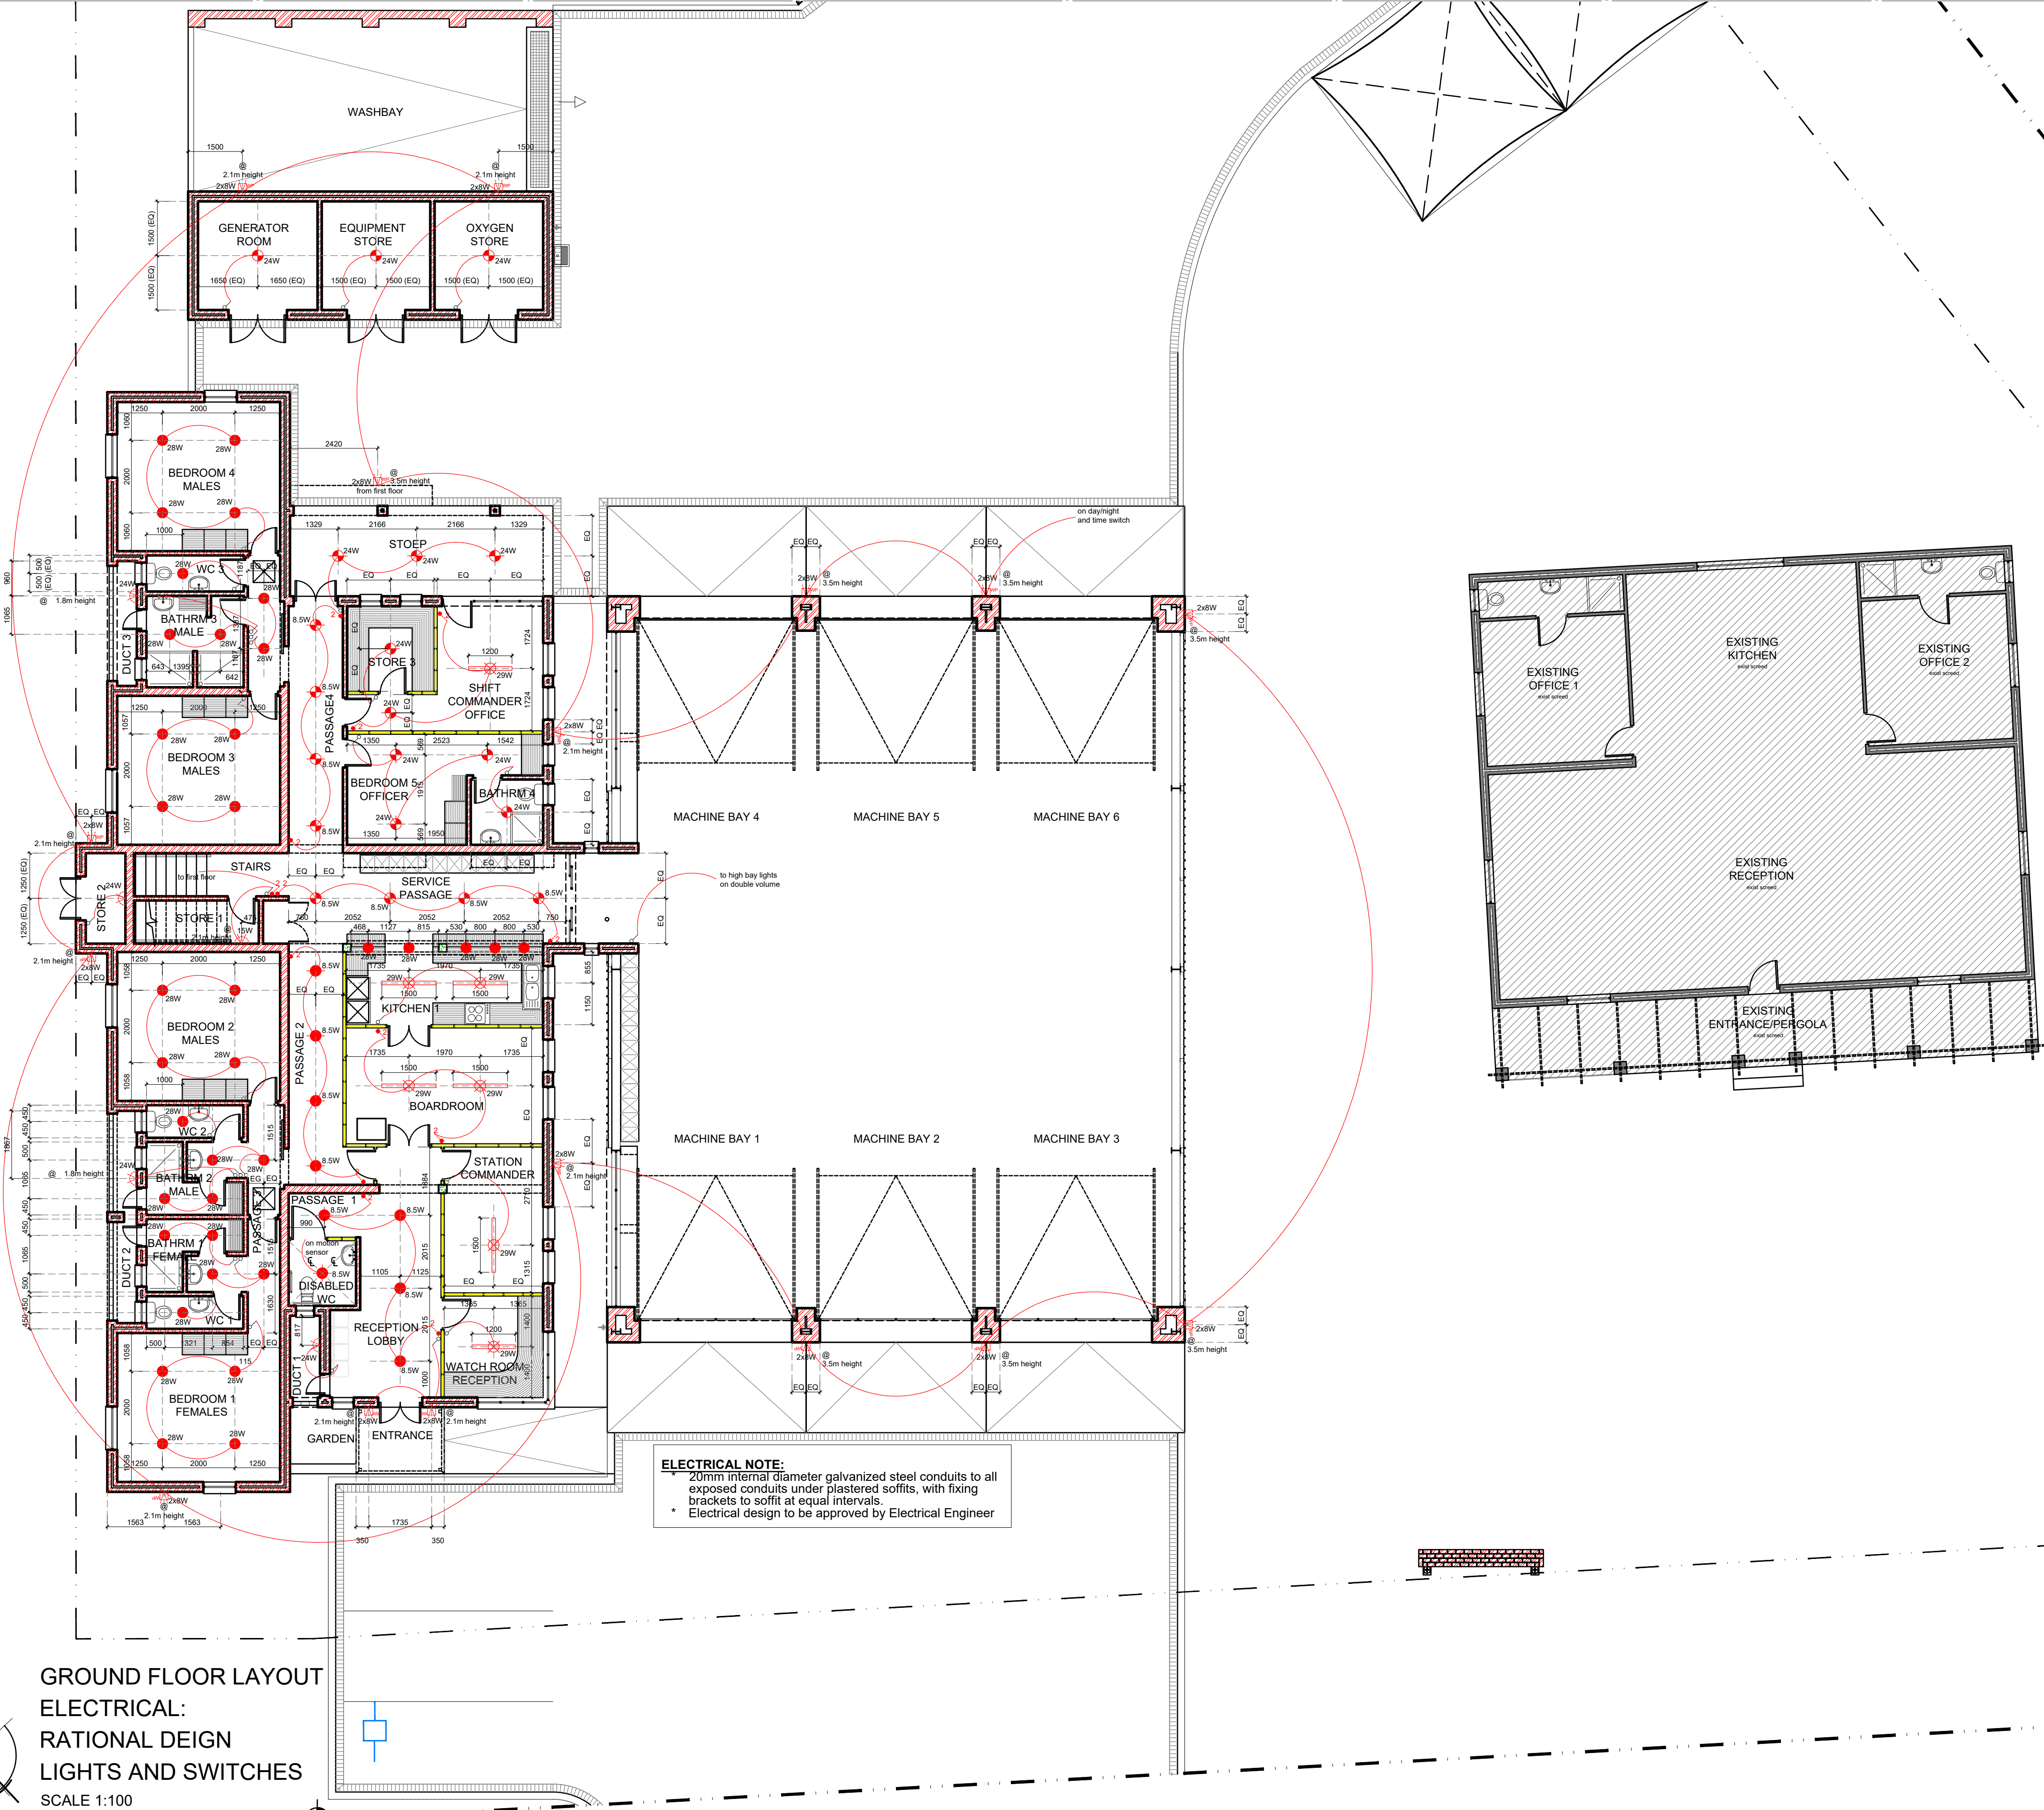

ELECTRICAL LEGEND		
	SURFACE MOUNTED LIGHT FITTING	
	LOW VOLTAGE RECESSED TILT DOWNLIGHT	
	SURFACE MOUNTED LOW VOLTAGE TILT DOWNLIGHT	
	HIGH BAY INDUSTRIAL LIGHT	
	WALL MOUNTED WEATHERPROOF LIGHT	
	WALL LIGHT - (1.8m HIGH)	
	FLUORESCENT SURFACE MOUNTED BRIGHTVIEW DIFFUSER IN 800, 1200 OR 1500MM LENGTHS	
	LIGHT SWITCH - "Viel Range" from LIGHTNING WAREHOUSE or similar approved	
	2 WAY SWITCH - "Viel Range" from LIGHTNING WAREHOUSE or similar approved	

ELECTRICAL NOTE:
• 20mm internal diameter galvanized steel conduits to all exposed conduits under plastered soffits, with fixing brackets to soffit at equal intervals.
• Electrical design to be approved by Electrical Engineer

GROUND FLOOR LAYOUT
ELECTRICAL:
RATIONAL DEIGN
LIGHTS AND SWITCHES
SCALE 1:100

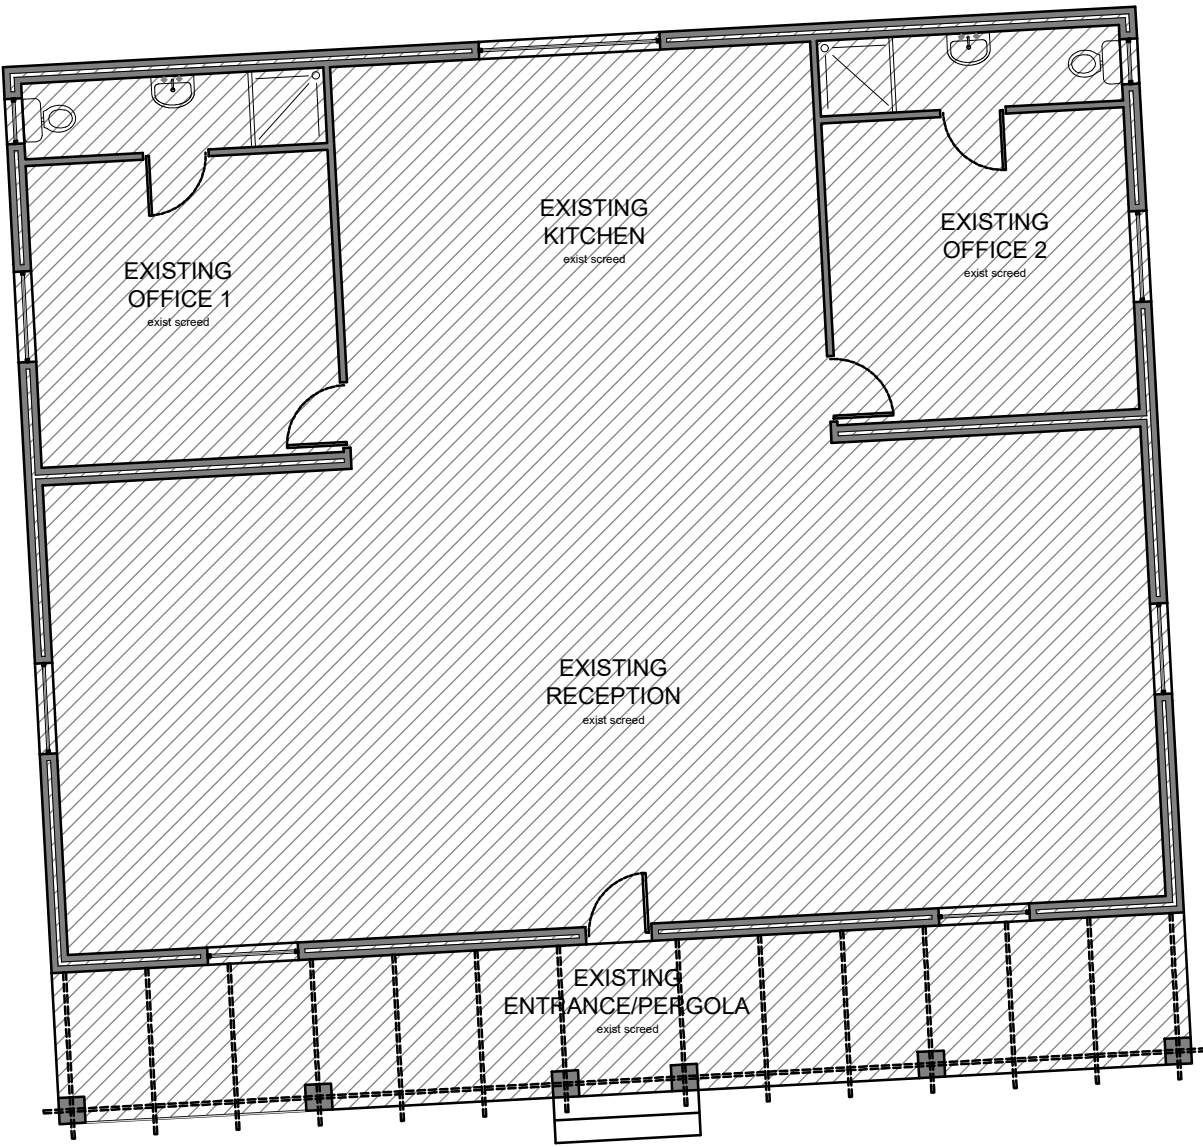

sign off architect:		sign off engineer:	

TENDER

**PROPOSED NEW
FIRE STATION for
LANGEBERG MUNICIPALITY**

ERF no: 8250
ROBERTSON

Tusk Construction Support Services
3 High Street
1st Floor
Rosenpark
Tygervalley
Belville
Cape Town
Tel: +27 (0) 21 424 4586/23
www.tuskcss.co.za

**ELECTRICAL
LIGHTS AND SWITCHES
GROUND FLOOR LEVEL**

Arch	1:100	2021.06.23
design:	drawn:	checked:
project:	drawn:	checked:
RFS/21	700	TEN