

This drawing is not to be scaled, all figured dimensions to be used.

All Dimensions and cadastral setting out information to be thoroughly checked on site and all or any discrepancies to be reported to the Architect or Lead Consultant before any work is put in hand.

All work is to comply with the NATIONAL BUILDING REGULATIONS (NBR) AND BUILDING STANDARDS act 103 of 1977 as amended

All work is to comply with all relevant specifications and codes of practice of the SOUTH AFRICAN BUREAU OF STANDARDS (SABS) / SOUTH AFRICAN NATIONAL STANDARDS (SANS) and amendments thereto.

HEALTH AND SAFETY: All construction activities to conform to the OCCUPATIONAL HEALTH AND SAFETY ACT 1993 (Act No 85 of 1993)

All materials and workmanship to be as per the MODEL PREAMBLES FOR TRADES 2008, and any further additional preambles as noted in the Bills of Quantities.

All work is to comply with all relevant specifications and codes of practice of the NATIONAL HOME BUILDERS REGISTRATION COUNCIL (NHBC) (Where applicable)

ELECTRICAL Engineer: (Where applicable) All materials and workmanship to be as specified on the Consultants drawings.






STRUCTURAL and CIVIL Engineer: (Where applicable) All materials and workmanship to be as specified on the Consultants drawings.

HVAC Engineer: (Where applicable) All materials and workmanship to be as specified on the Consultants drawings.

RATIONAL FIRE Engineer: (Where applicable) All materials and workmanship to be as specified on the Consultants drawings.


WET SERVICES Engineer: (Where applicable) All materials and workmanship to be as specified on the Consultants drawings.

SPECIALIST CONSULTANTS (Where applicable) All materials and workmanship to be as specified on the Consultants drawing.

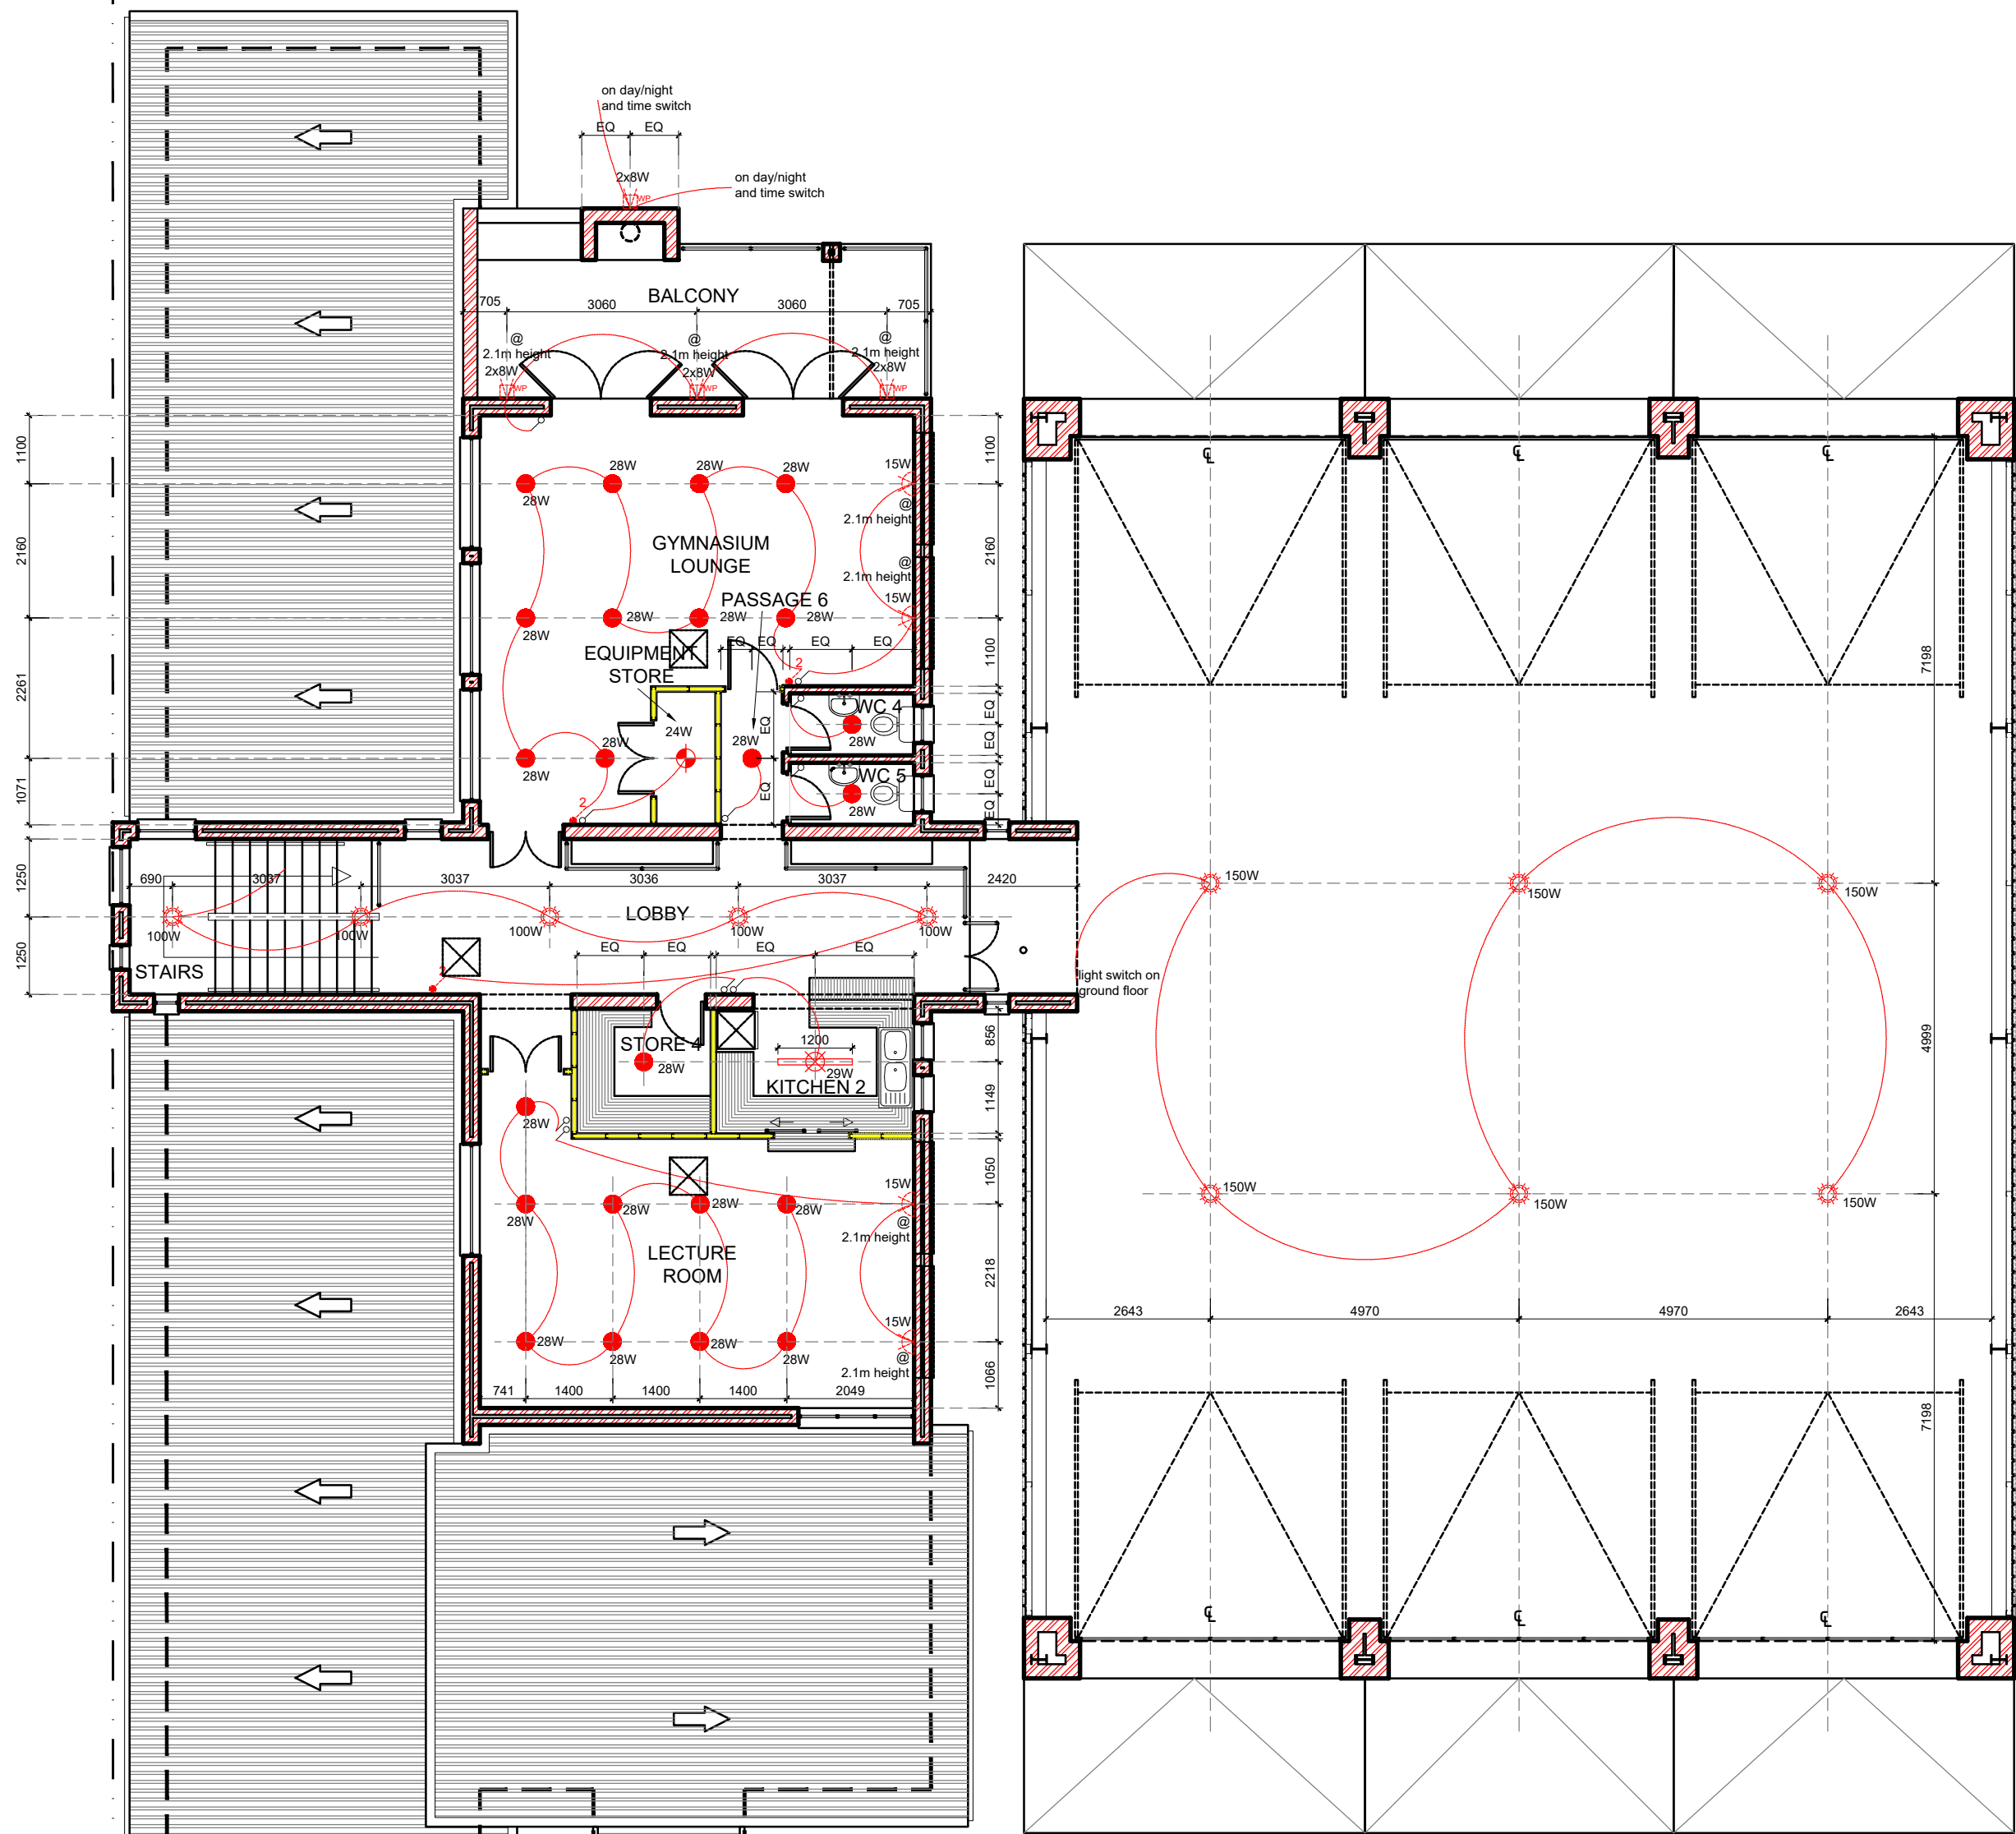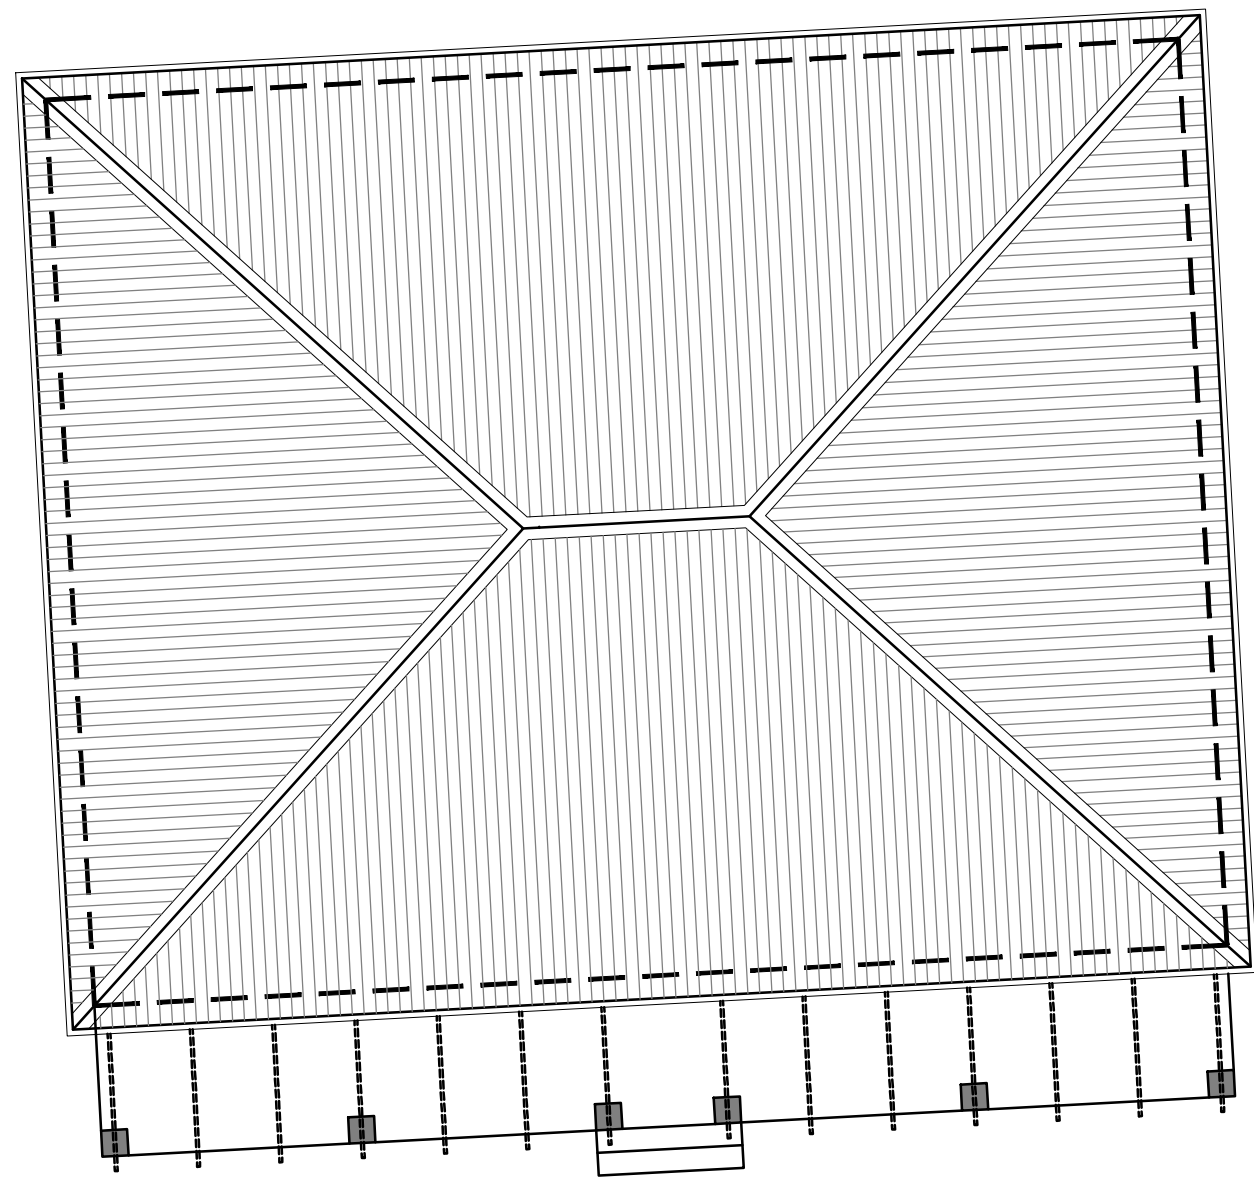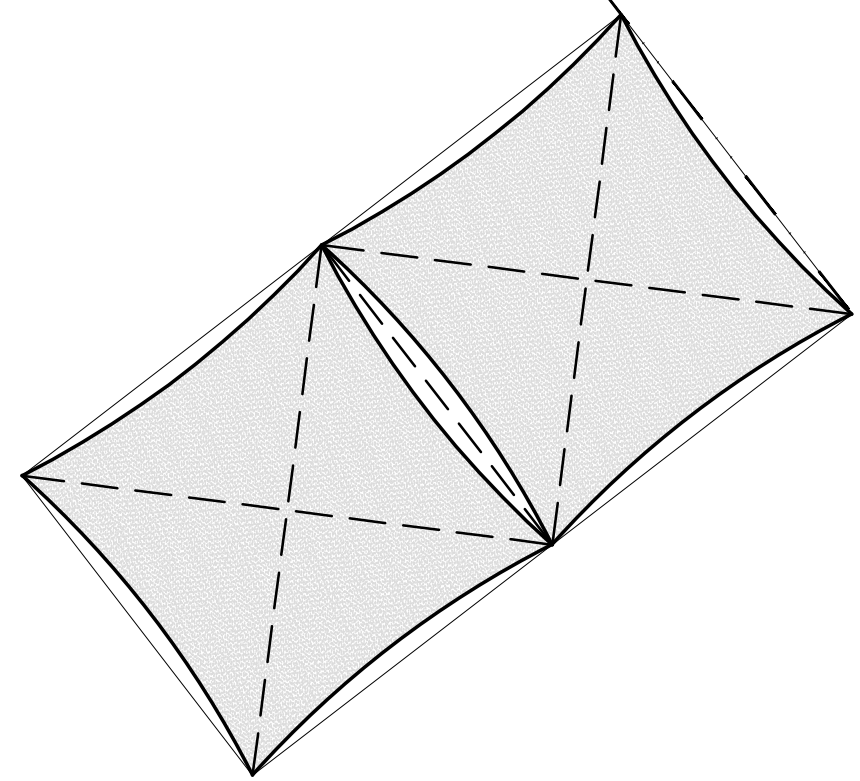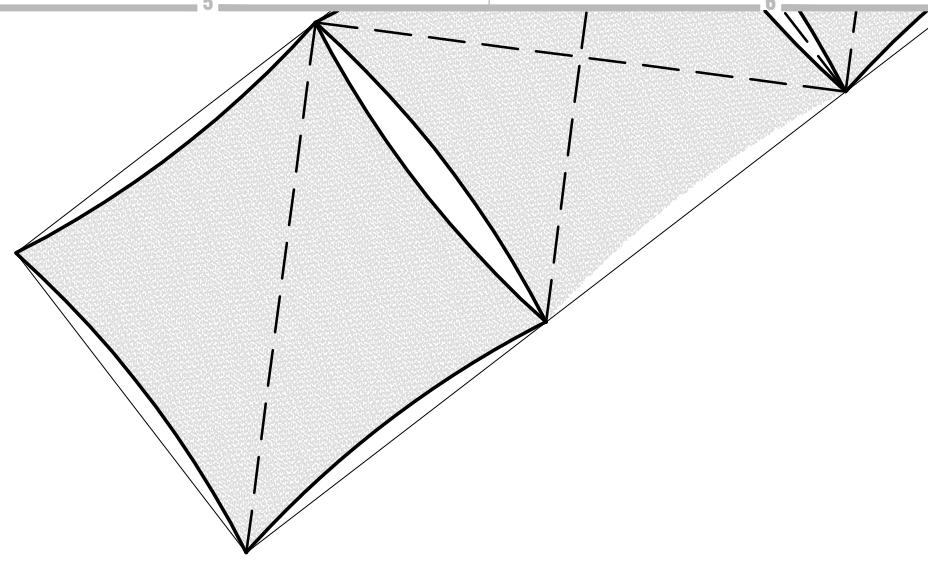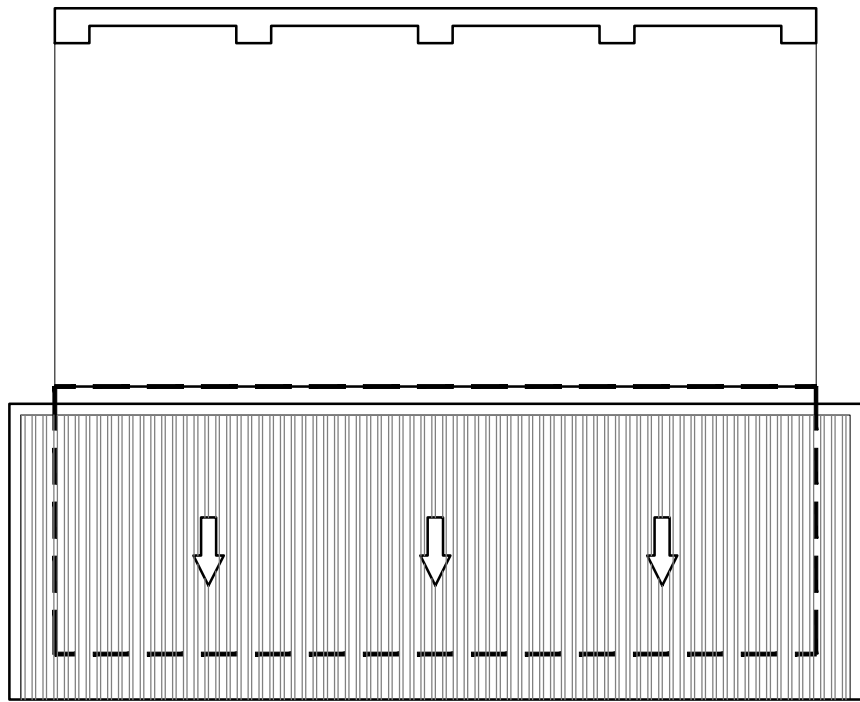

ELECTRICAL NOTE:
20mm internal diameter galvanized steel conduits to all exposed conduits under plastered soffits, with fixing brackets to soffit at equal intervals.
• Electrical design to be approved by Electrical Engineer

ELECTRICAL LEGEND	
	SURFACE MOUNTED LIGHT FITTING colour: black
	LOW VOLTAGE RECESSED TILT DOWNLIGHT colour: black
	SURFACE MOUNTED LOW VOLTAGE TILT DOWNLIGHT colour: black
	HIGH BAY INDUSTRIAL LIGHT colour: black
	WALL MOUNTED WEATHERPROOF LIGHT colour: black
	WALL LIGHT - (1.8m HIGH) colour: black
	FLUORESCENT SURFACE MOUNTED BRIGHTVIEW DIFFUSER IN 900, 1200 OR 1500MM LENGTHS colour: black
	LIGHT SWITCH - "Viel Range" from LIGHTNING WAREHOUSE or similar approved colour: black
	2 WAY SWITCH - "Viel Range" from LIGHTNING WAREHOUSE or similar approved colour: black

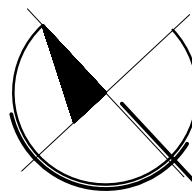

FIRST FLOOR LAYOUT
ELECTRICAL:
RATIONAL DESIGN
LIGHTS AND SWITCHES
SCALE 1:100

sign off architect:	sign off engineer:

TEN	Issued for TENDER	TG	2022.06.31
B	Issued for SUBMISSION	TG	2021.11.02
A	Issued for INFORMATION	TG	2021.09.23
rev:	description:	by:	date:

TENDER

PROPOSED NEW
FIRE STATION for
LANGEBERG MUNICIPALITY

ERF 8250
ROBERTSON



Tusk Construction Support Services
3 High Street
1st Floor
Rosenpark
Tygervalley
Belville
Cape Town
Tel: +27 (0) 21 424 4586/23
www.tuskcss.co.za

ARCHITECTURE

ELECTRICAL
LIGHTS AND SWITCHES
FIRST FLOOR LEVEL

Arch	1:100	2021.06.23
discipline:	scale:	date:
AN	TG	AN
design:	drawn:	checked:
project:	drawn no:	rev:
RFS/21	701	TEN