


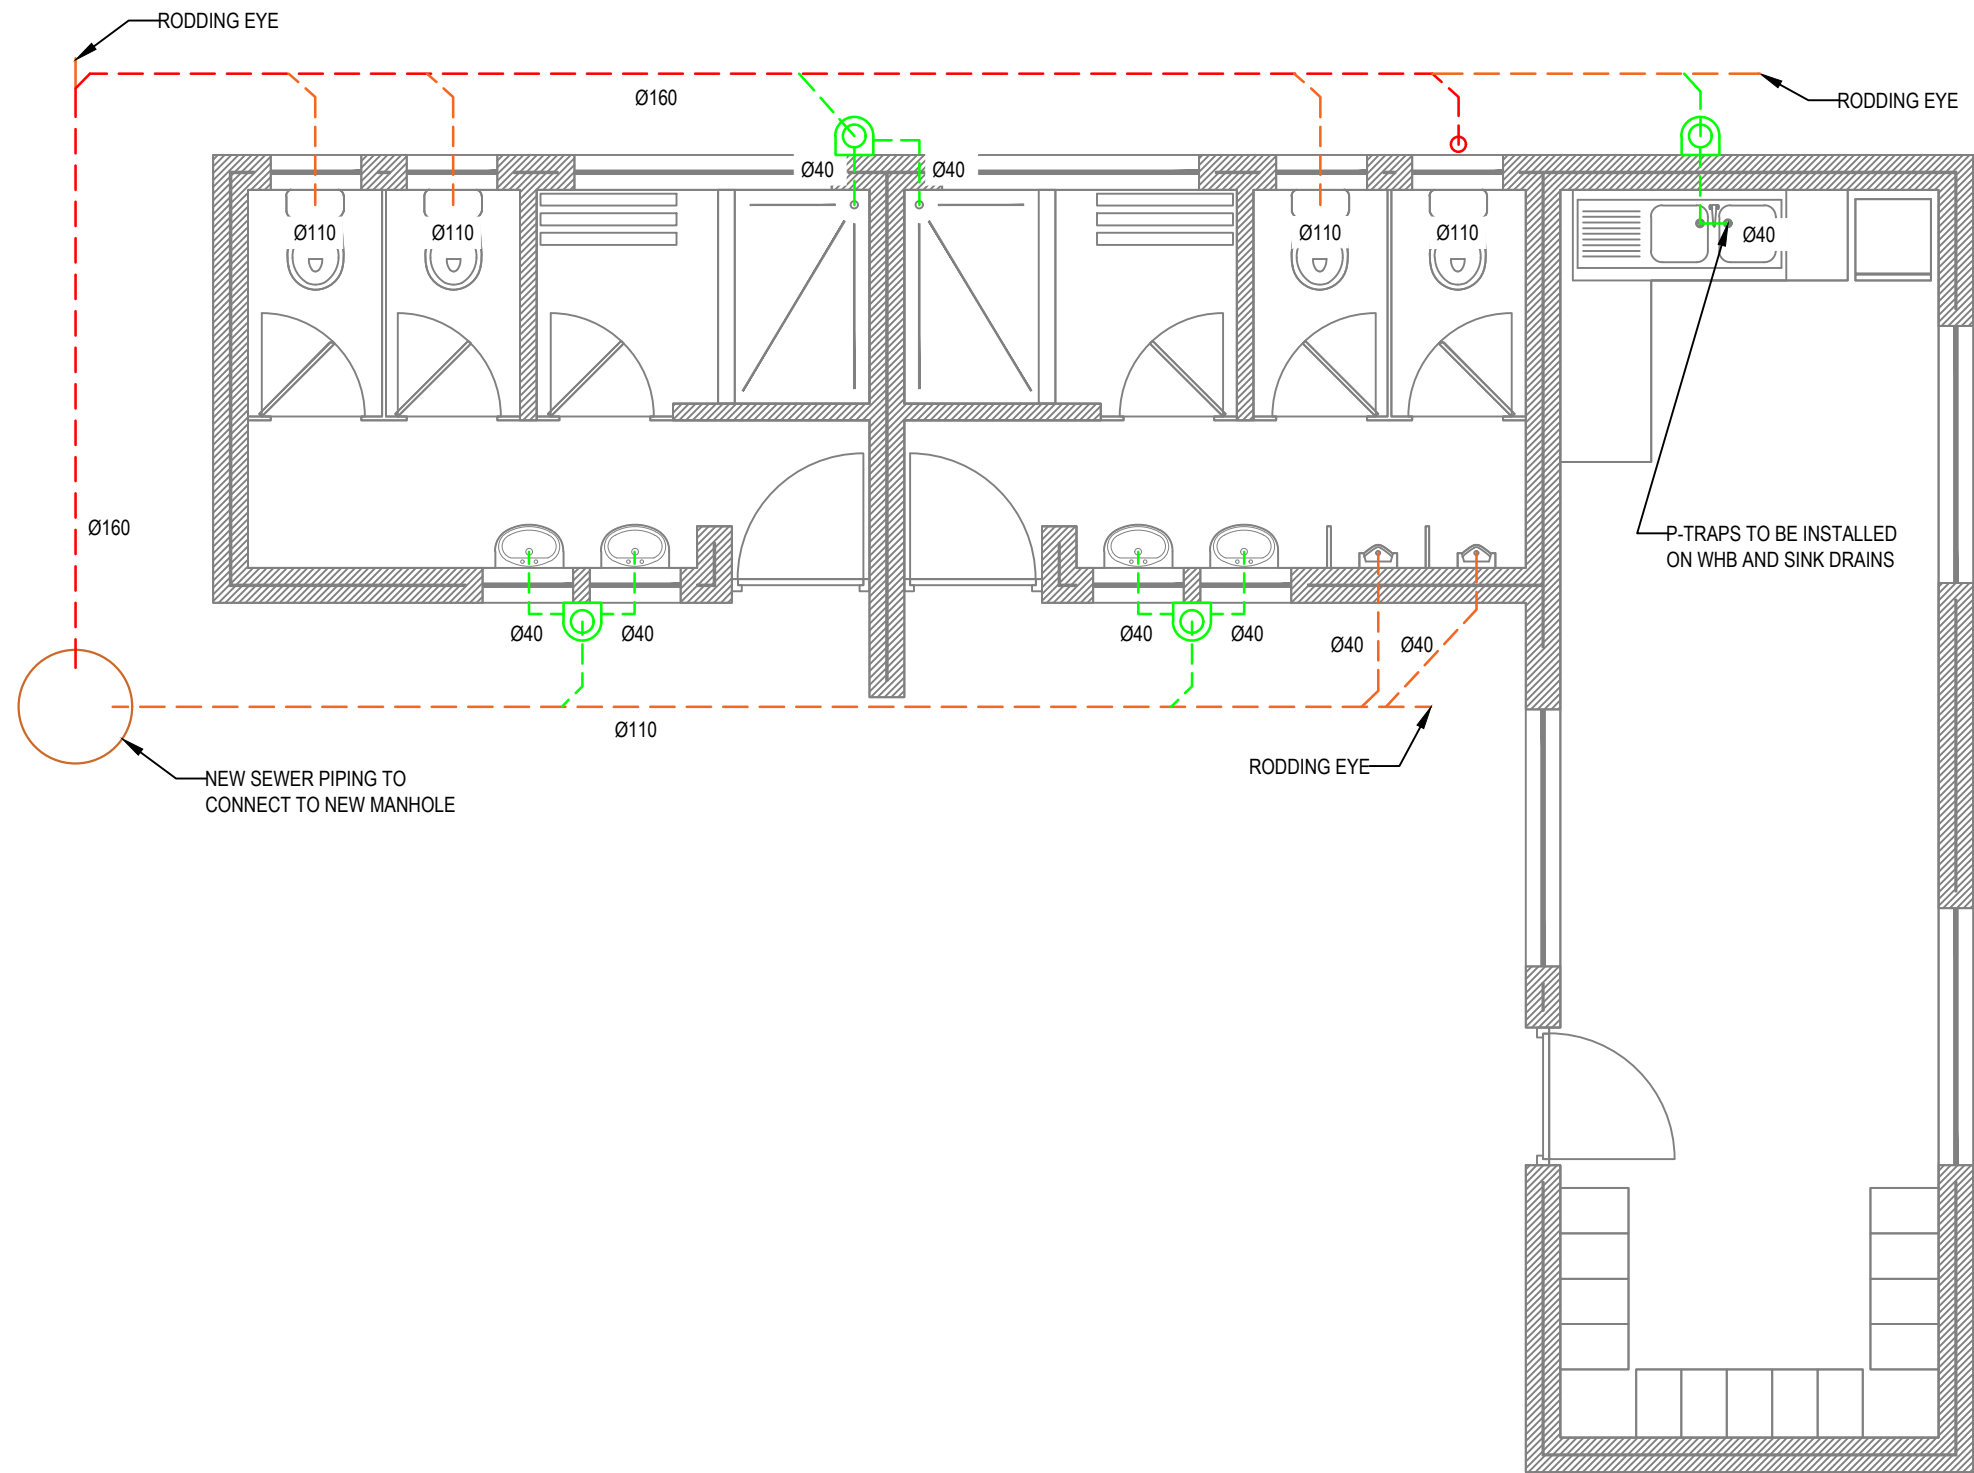


ABLUTIONS DRAINAGE LAYOUT SCALE 1:50

LEGEND:	
B	BATH
CD	CONDENSATE DRAIN
DF	DRINKING FOUNTAIN
DW	DISHWASHER
FD	FLOOR DRAIN
GT	GREASE TRAP
PB	PREP BOWL
RE	RODDING EYE
S	SINK
SH	SHOWER
WC	WATER CLOSET
WHB	WASH HAND BASIN
WM	WASHING MACHINE
UR	URINAL
SHF	SLOP HOPPER
TB	TO BELOW
DN	DN
UP	UP
—	VENT PIPE
—	COMBINED SOIL & VENT PIPE
—	WASTE PIPE
—	SOIL & DRAIN PIPE
—	PIPE RUN SUB-SURFACE
---	PIPE UNDER SOFFIT / IN CEILING SPACE
...	PIPE IN WALL / MID-LEVEL

- PLUMBING NOTES:
1. DRAINAGE INSTALLATION TO COMPLY WITH SANS 10252.
 2. ALL DETAILS, DIMENSIONS AND LEVELS TO BE CHECKED ON SITE BEFORE COMMENCEMENT OF WORK.
 3. ALL FITTINGS TO BE SAME MANUFACTURER AS THE PIPES AND ALL CUTTING AND JOINTING ON SITE TO BE IN ACCORDANCE WITH THE MANUFACTURER'S SPECIFICATIONS.
 4. PIPING AND FITTINGS TO BE CLEARED OF ALL DEBRIS AT FINAL INSPECTION AND HANDOVER OF THE PROJECT. ADEQUATE ACCESS TO BE PROVIDED FOR INSPECTION, TESTING AND MAINTENANCE.
 5. AS BUILT DRAWINGS TO BE PRODUCED BY THE PLUMBER AND ISSUED TO THE ENGINEER.
 6. ALL SETTING OUT TO BE DONE TO THE ARCHITECTS DRAWINGS AND DIMENSIONS.

0 5 10 15 20 30 50mm
ORIGINAL SIZE A3

Rev.	Date	Description	Rev. by
B	26/04/2022	FOR TENDER	MM
A	28/02/2022	FOR INFORMATION	MM

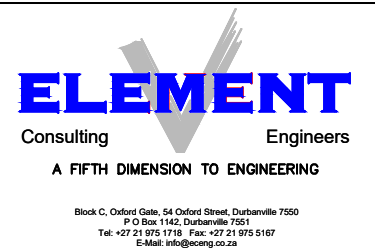

Project

ASHTON
MATERIAL RECOVERY FACILITY

Plan Description

SANITARY DRAINAGE
ABLUTIONS

Designed	PF	Scale	1:50
Drawn	MM	Date	FEB 2022
Checked	PF	Approved	
	20160846		

Contract No.

2104161

Drawing No.

2104161/M/400

ARCHITECT	-
Project/DWG No.	2104161 - ASHTON MRF CIVIL SERVICES
REvision	-
Date Received	25/02/22

Revision	A	B							
COPYRIGHT IS VESTED IN ELEMENT CONSULTING ENGINEERS (PTY) LTD IN TERMS OF THE COPYRIGHT ACT (ACT 98 OF 1978)									

P:\Durbanville\2021\2104161 - Ashton Material Recovery Facility\03 - Working Drawings\03 - Mechanical\Drawings\2104161-M-400-Rev B.dwg